



INCOMING WATER FROM WELL OR WATER SUPPLY. Location may be revised to suit well or supply location shown on the Site Plan.

INCOMING PROPANE LINE OR NATURAL GAS LINE. Location may be revised to suit gas service line for natural gas installations. See Site Plan for location of propane tank or gas service line.



NOT TO BE ON SCALE HOUSE

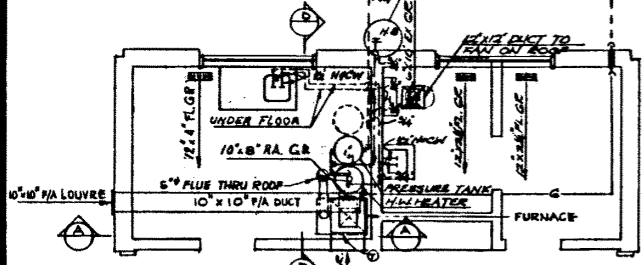


FLOOR PLAN SCALE 1/4"=1'-0"

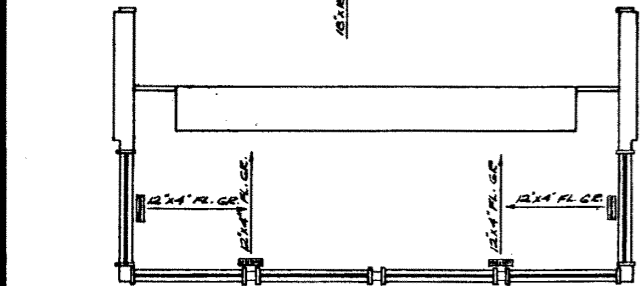


FOUNDATION PLAN 1/4"=1'-0"

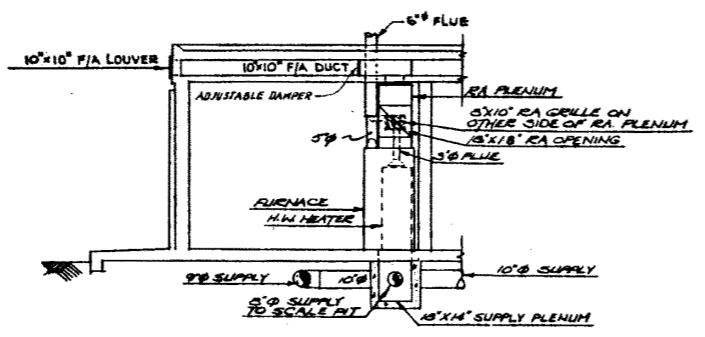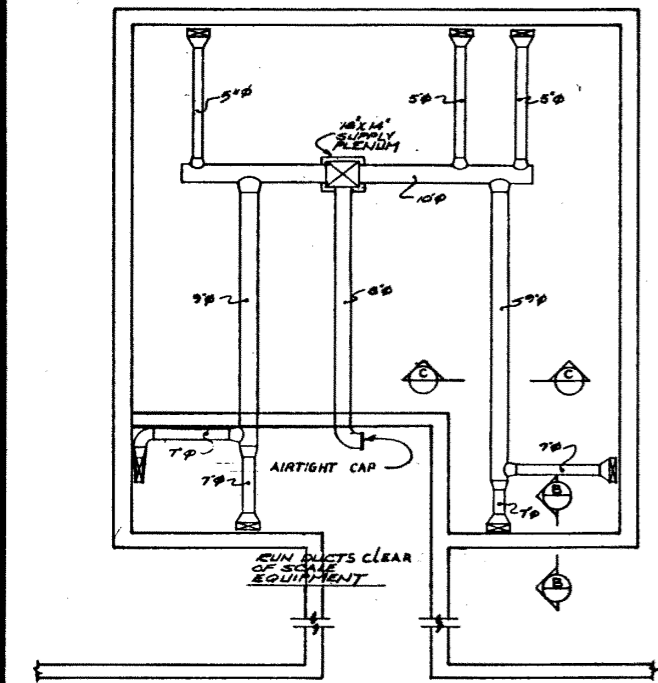


SECTION A 1/4"=1'-0"

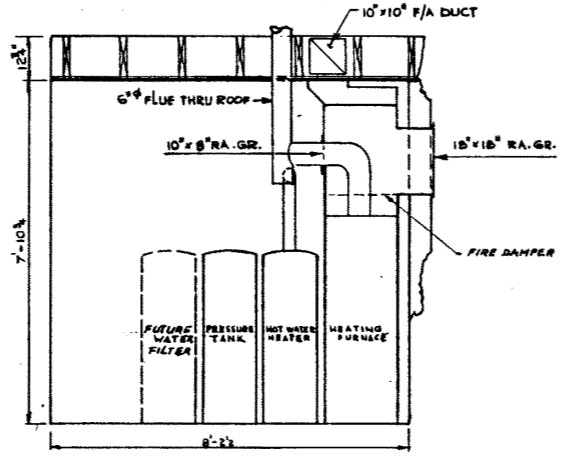

SECTION B 1/2"=1'-0"

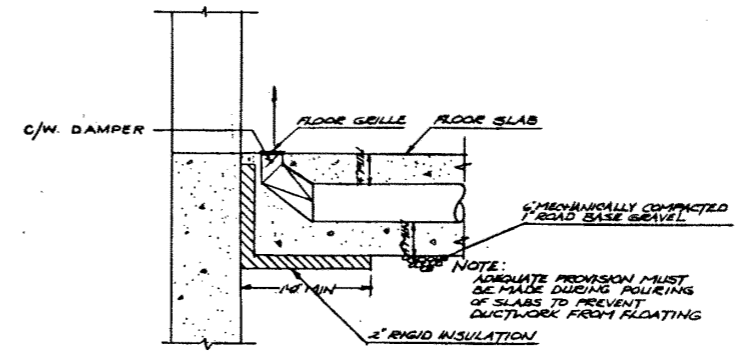

SECTION C N.T.S.

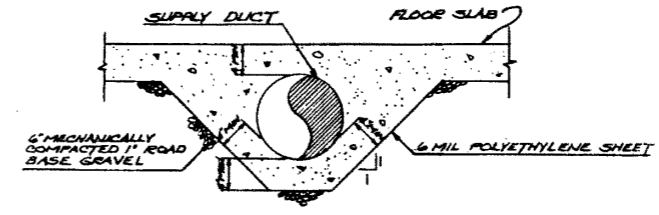

SECTION D N.T.S.

GENERAL NOTES:
Walls adjacent to furnace to be asbestos sheeted to suit fire regulations.

SUPERSEDED
By Dwg. S-998

2

DESIGNED		DRAWN BY		DATE		CHECKED BY		DATE		STREAM		LOCATION		HWY. NO.		SCALE		FILE NO.		SHEET		DWG. NO.	
		T. Speller		July 71		J.R. Chaman		Aug 71								shown		3235		of 5		S-998-71	

APPROVED		PROVINCE OF ALBERTA DEPARTMENT OF HIGHWAYS AND TRANSPORT BRIDGE BRANCH	
_____ CHIEF BRIDGE ENGINEER		WEIGH SCALE STATION HEATING, VENTILATING AND WATER SYSTEMS	