

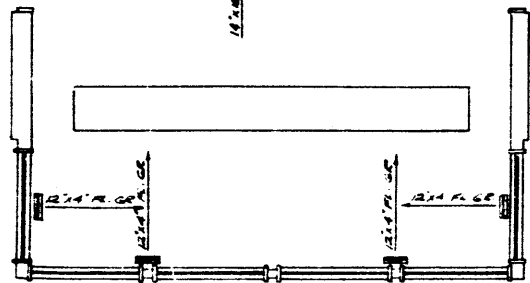


INCOMING WATER FROM WELL OR WATER SUPPLY. Location may be revised to suit well or supply location shown on the 'Site Plan'.


INCOMING PROPANE LINE OR NATURAL GAS LINE. Location may be revised to suit gas service line for natural gas installations. See Site Plan for location of propane tank or gas service line.

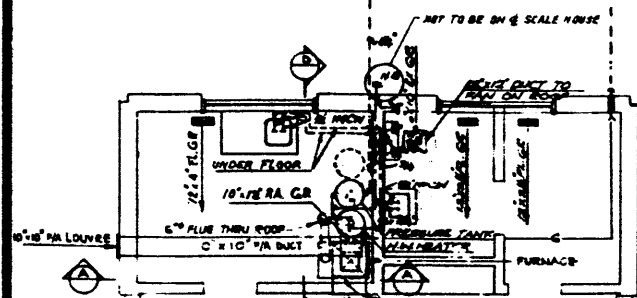


FLOOR PLAN  
SCALE 1/4" = 1'-0"

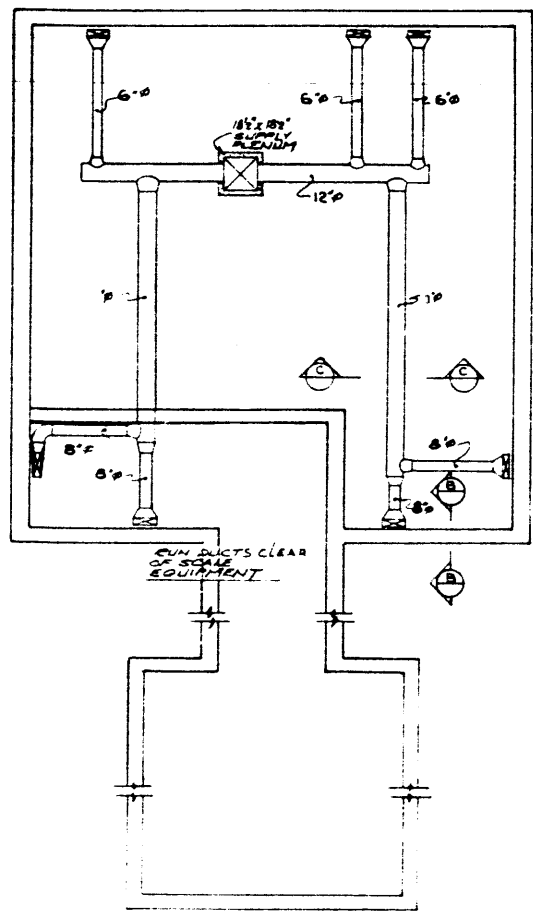


FOUNDATION PLAN  
1/4" = 1'-0"

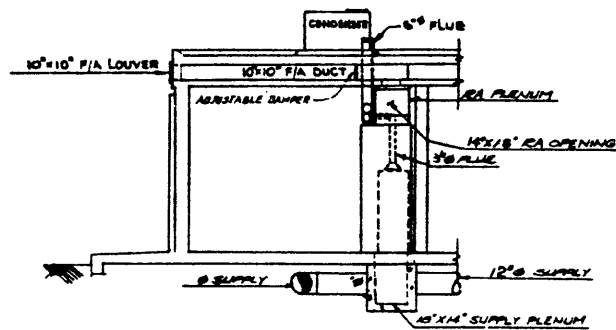


A SECTION  
1/4" = 1'-0"

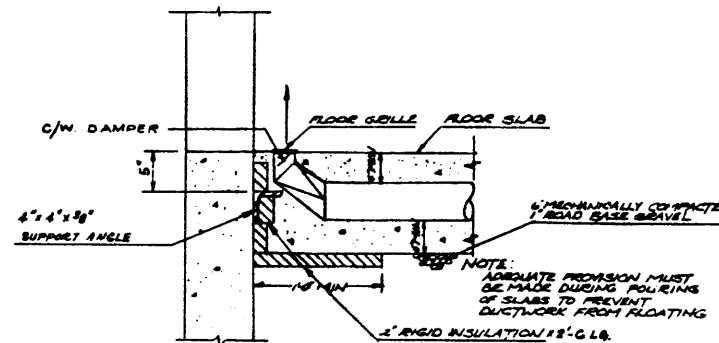

B SECTION  
1/75

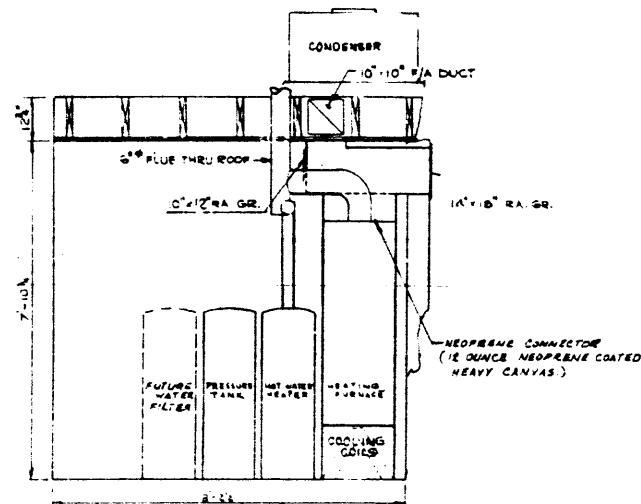

D SECTION  
3/16"

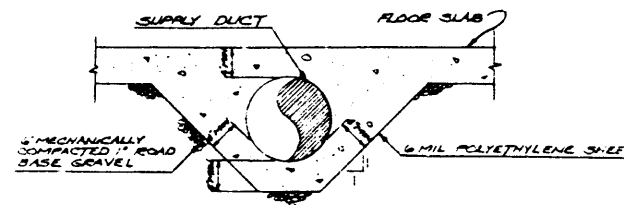

C SECTION  
1/75

Taken from D.P.W. 2-73

4

DESIGNED		DRAWN BY		DATE		CHECKED BY		DATE		STREAM		LOCATION		REV. NO.		SCALE		FILE NO.		SHEET		DRAWING NO.	
R.M.L.		T. Spater		APRIL 76												DRAWN		3235		OF		S-998-76	

PROVINCE OF ALBERTA  
DEPARTMENT OF HIGHWAYS AND TRANSPORT  
BRIDGE BRANCH

WEIGH SCALE STATION  
HEATING, VENTILATING  
AND WATER SYSTEMS