



INCOMING WATER FROM WELL
Location may be revised to suit well location shown on Site Plan.


INCOMING PROPANE LINE OR NATURAL GAS LINE
Location may be revised to suit gas service line for natural gas installations. See Site Plan for location of propane tank or gas service line.

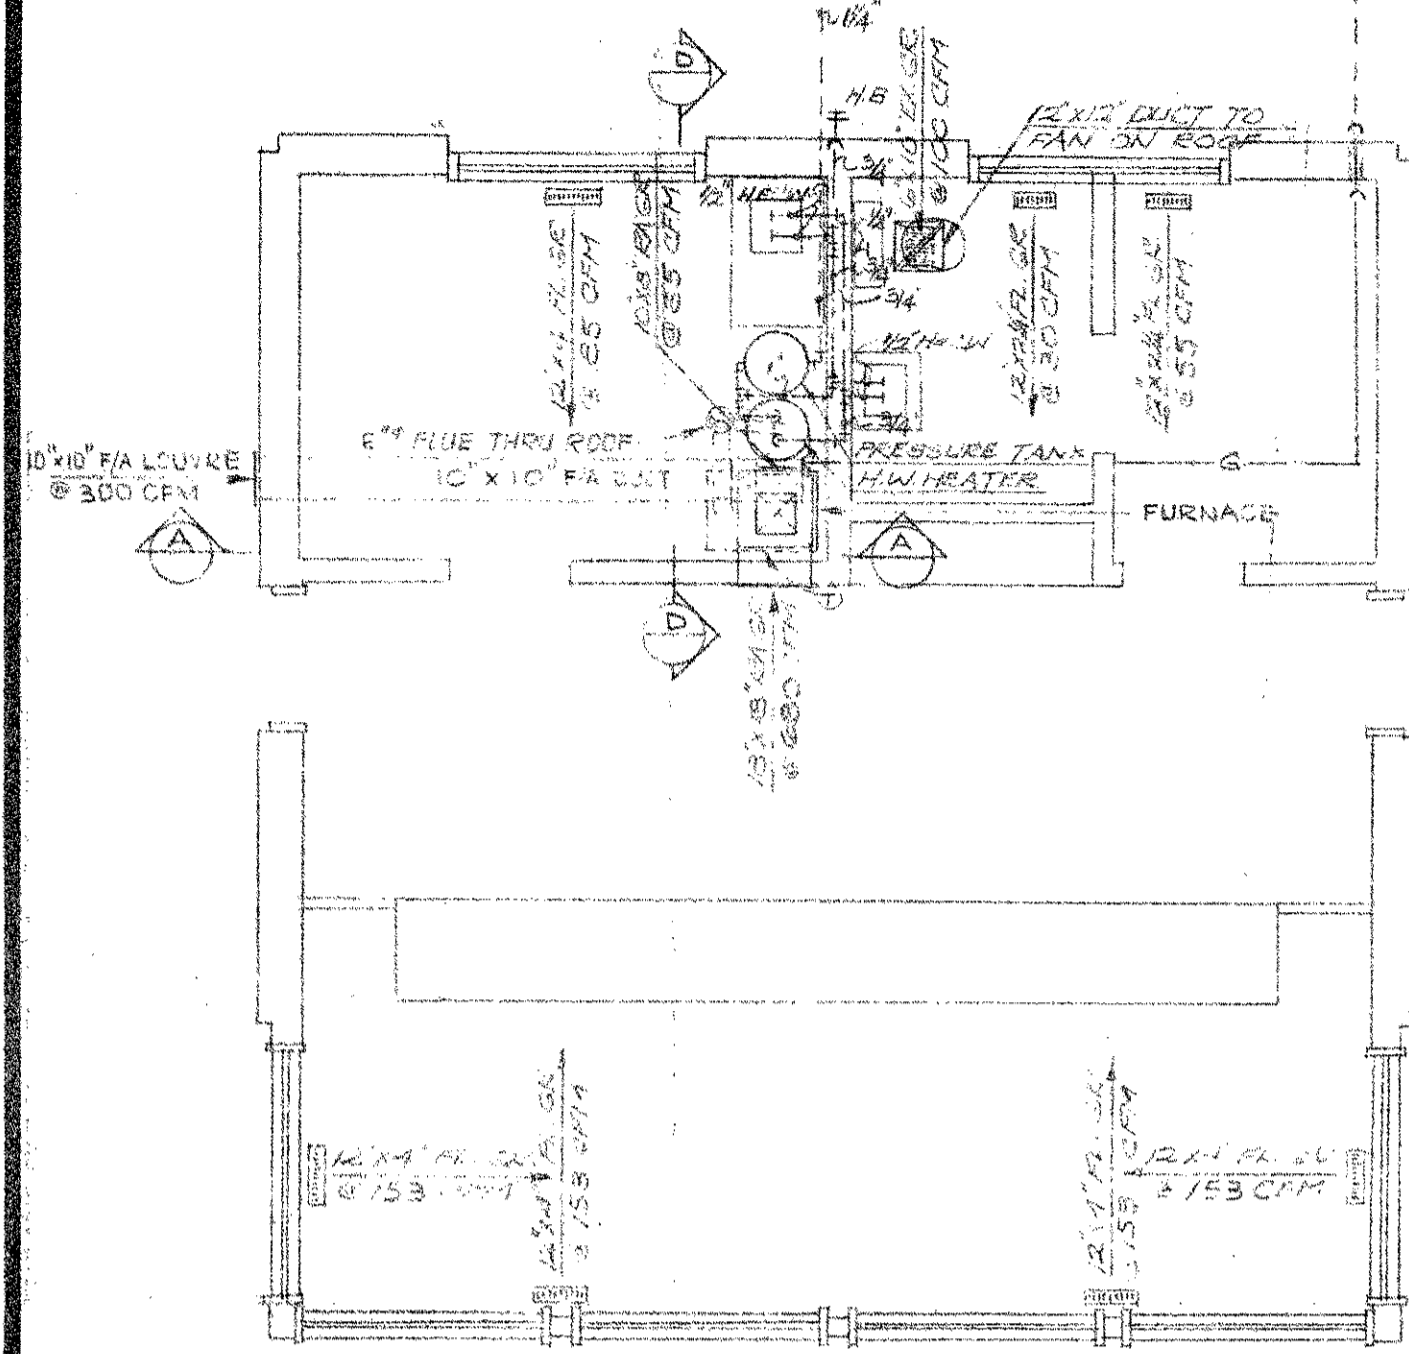


FLOOR PLAN
SCALE 1/4"=1'-0"

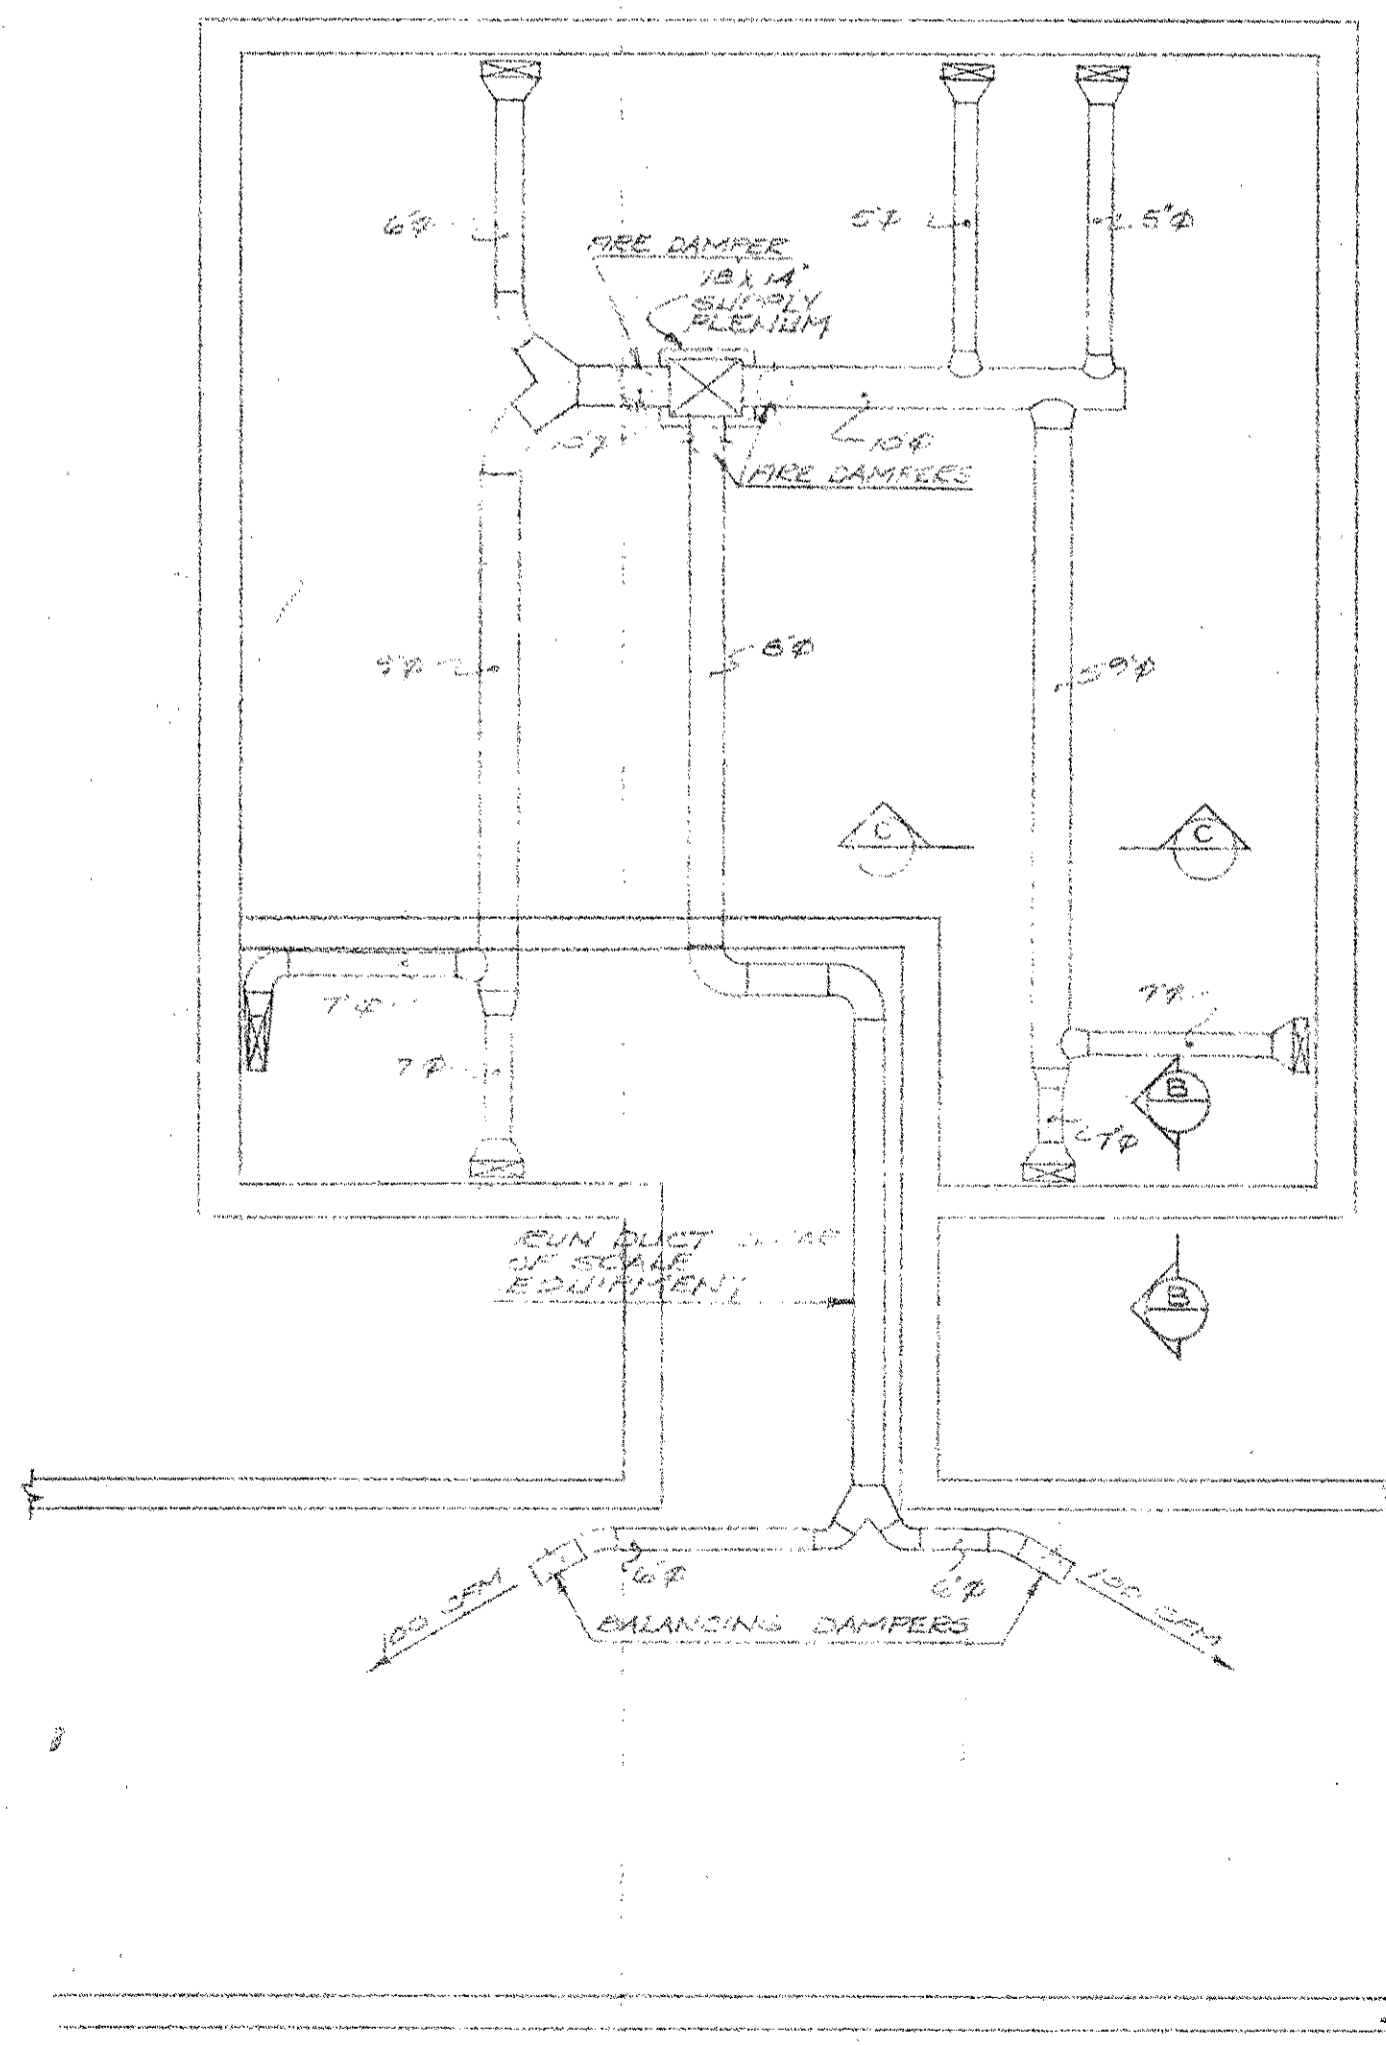


FOUNDATION PLAN
SCALE 1/4"=1'-0"

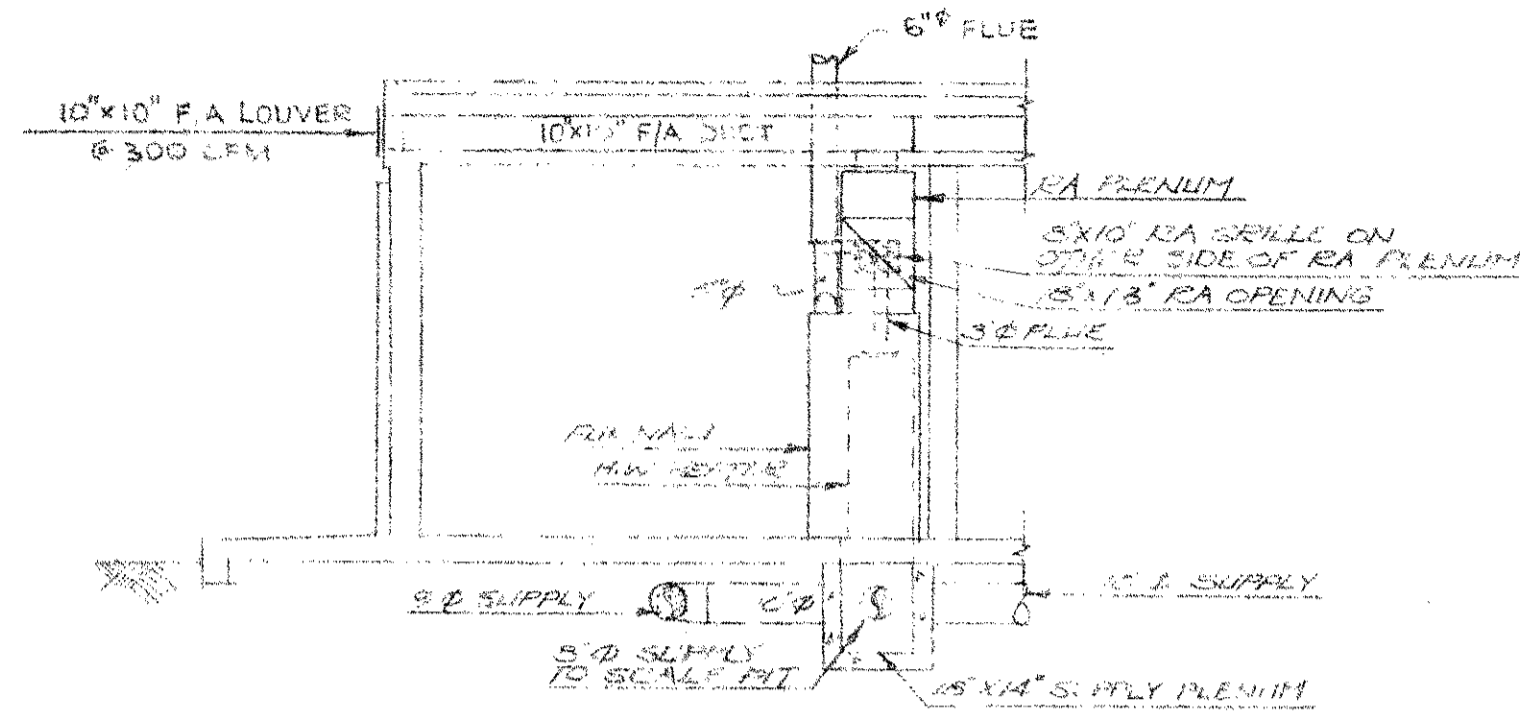


A SECTION
SCALE 1/2"=1'-0"

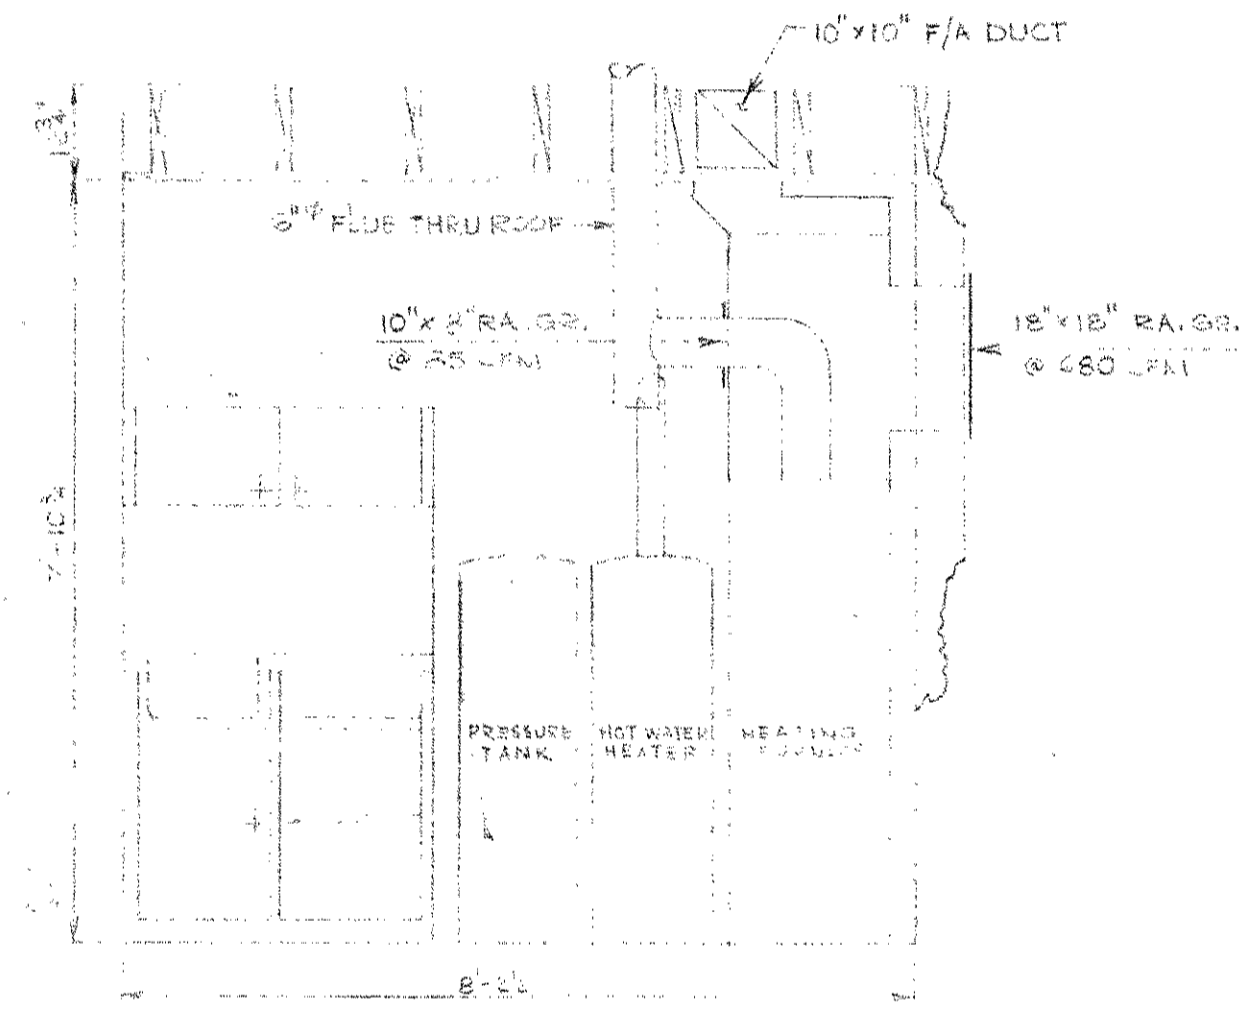

D SECTION
SCALE 1/2"=1'-0"

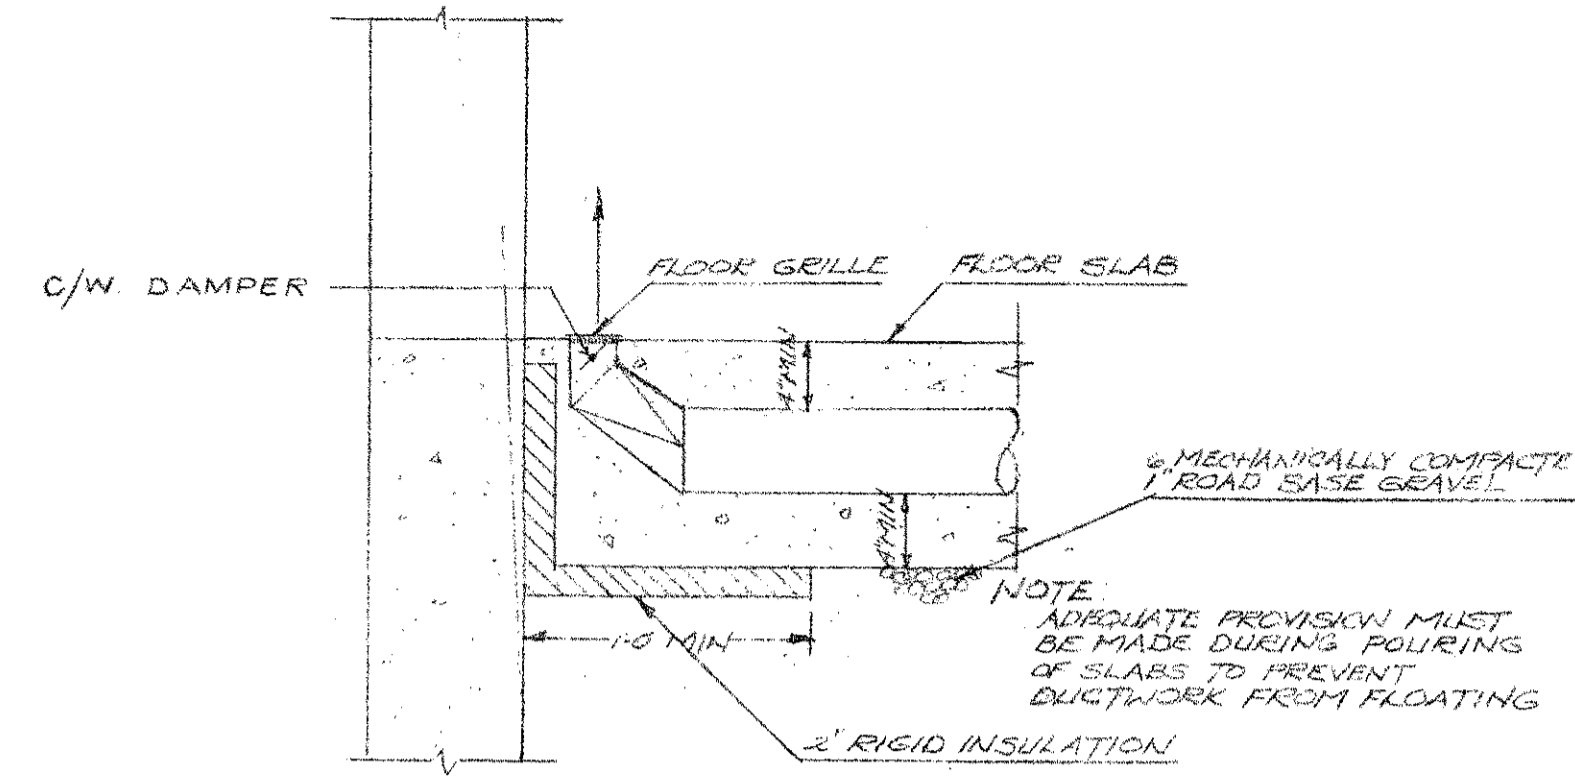

B SECTION
SCALE N.T.S.

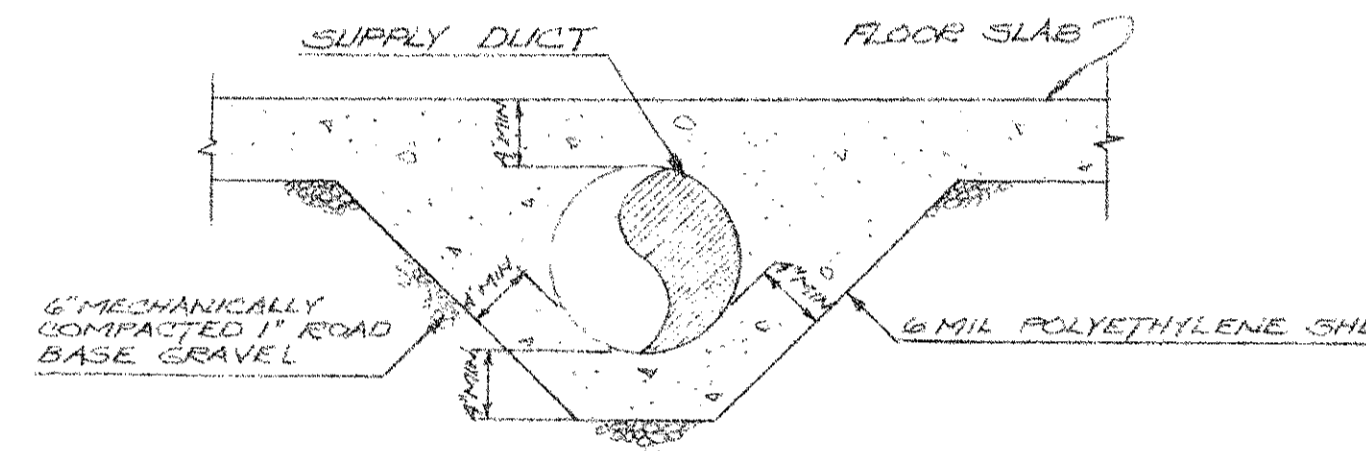

C SECTION
SCALE N.T.S.

DESIGNED BY _____ DATE _____ 19____
 DETAILED BY _____ DATE _____ 19____
 CHECKED BY _____ DATE _____ 19____

SUPERSEDED

Aug. 24th 71 By S-998-71

WEIGH SCALE STATION
 HEATING, VENTILATING
 AND WATER SYSTEMS

GOVERNMENT OF THE PROVINCE OF ALBERTA
 DEPARTMENT OF HIGHWAYS
 BRIDGE BRANCH, EDMONTON

FILE NO. 3235 HWY. NO. _____ DWG. NO. S-998
 LOCATION _____ SCALE as shown
 STREAM _____ SHEET _____ OF _____

NO.	DATE	DESCRIPTION	BY